


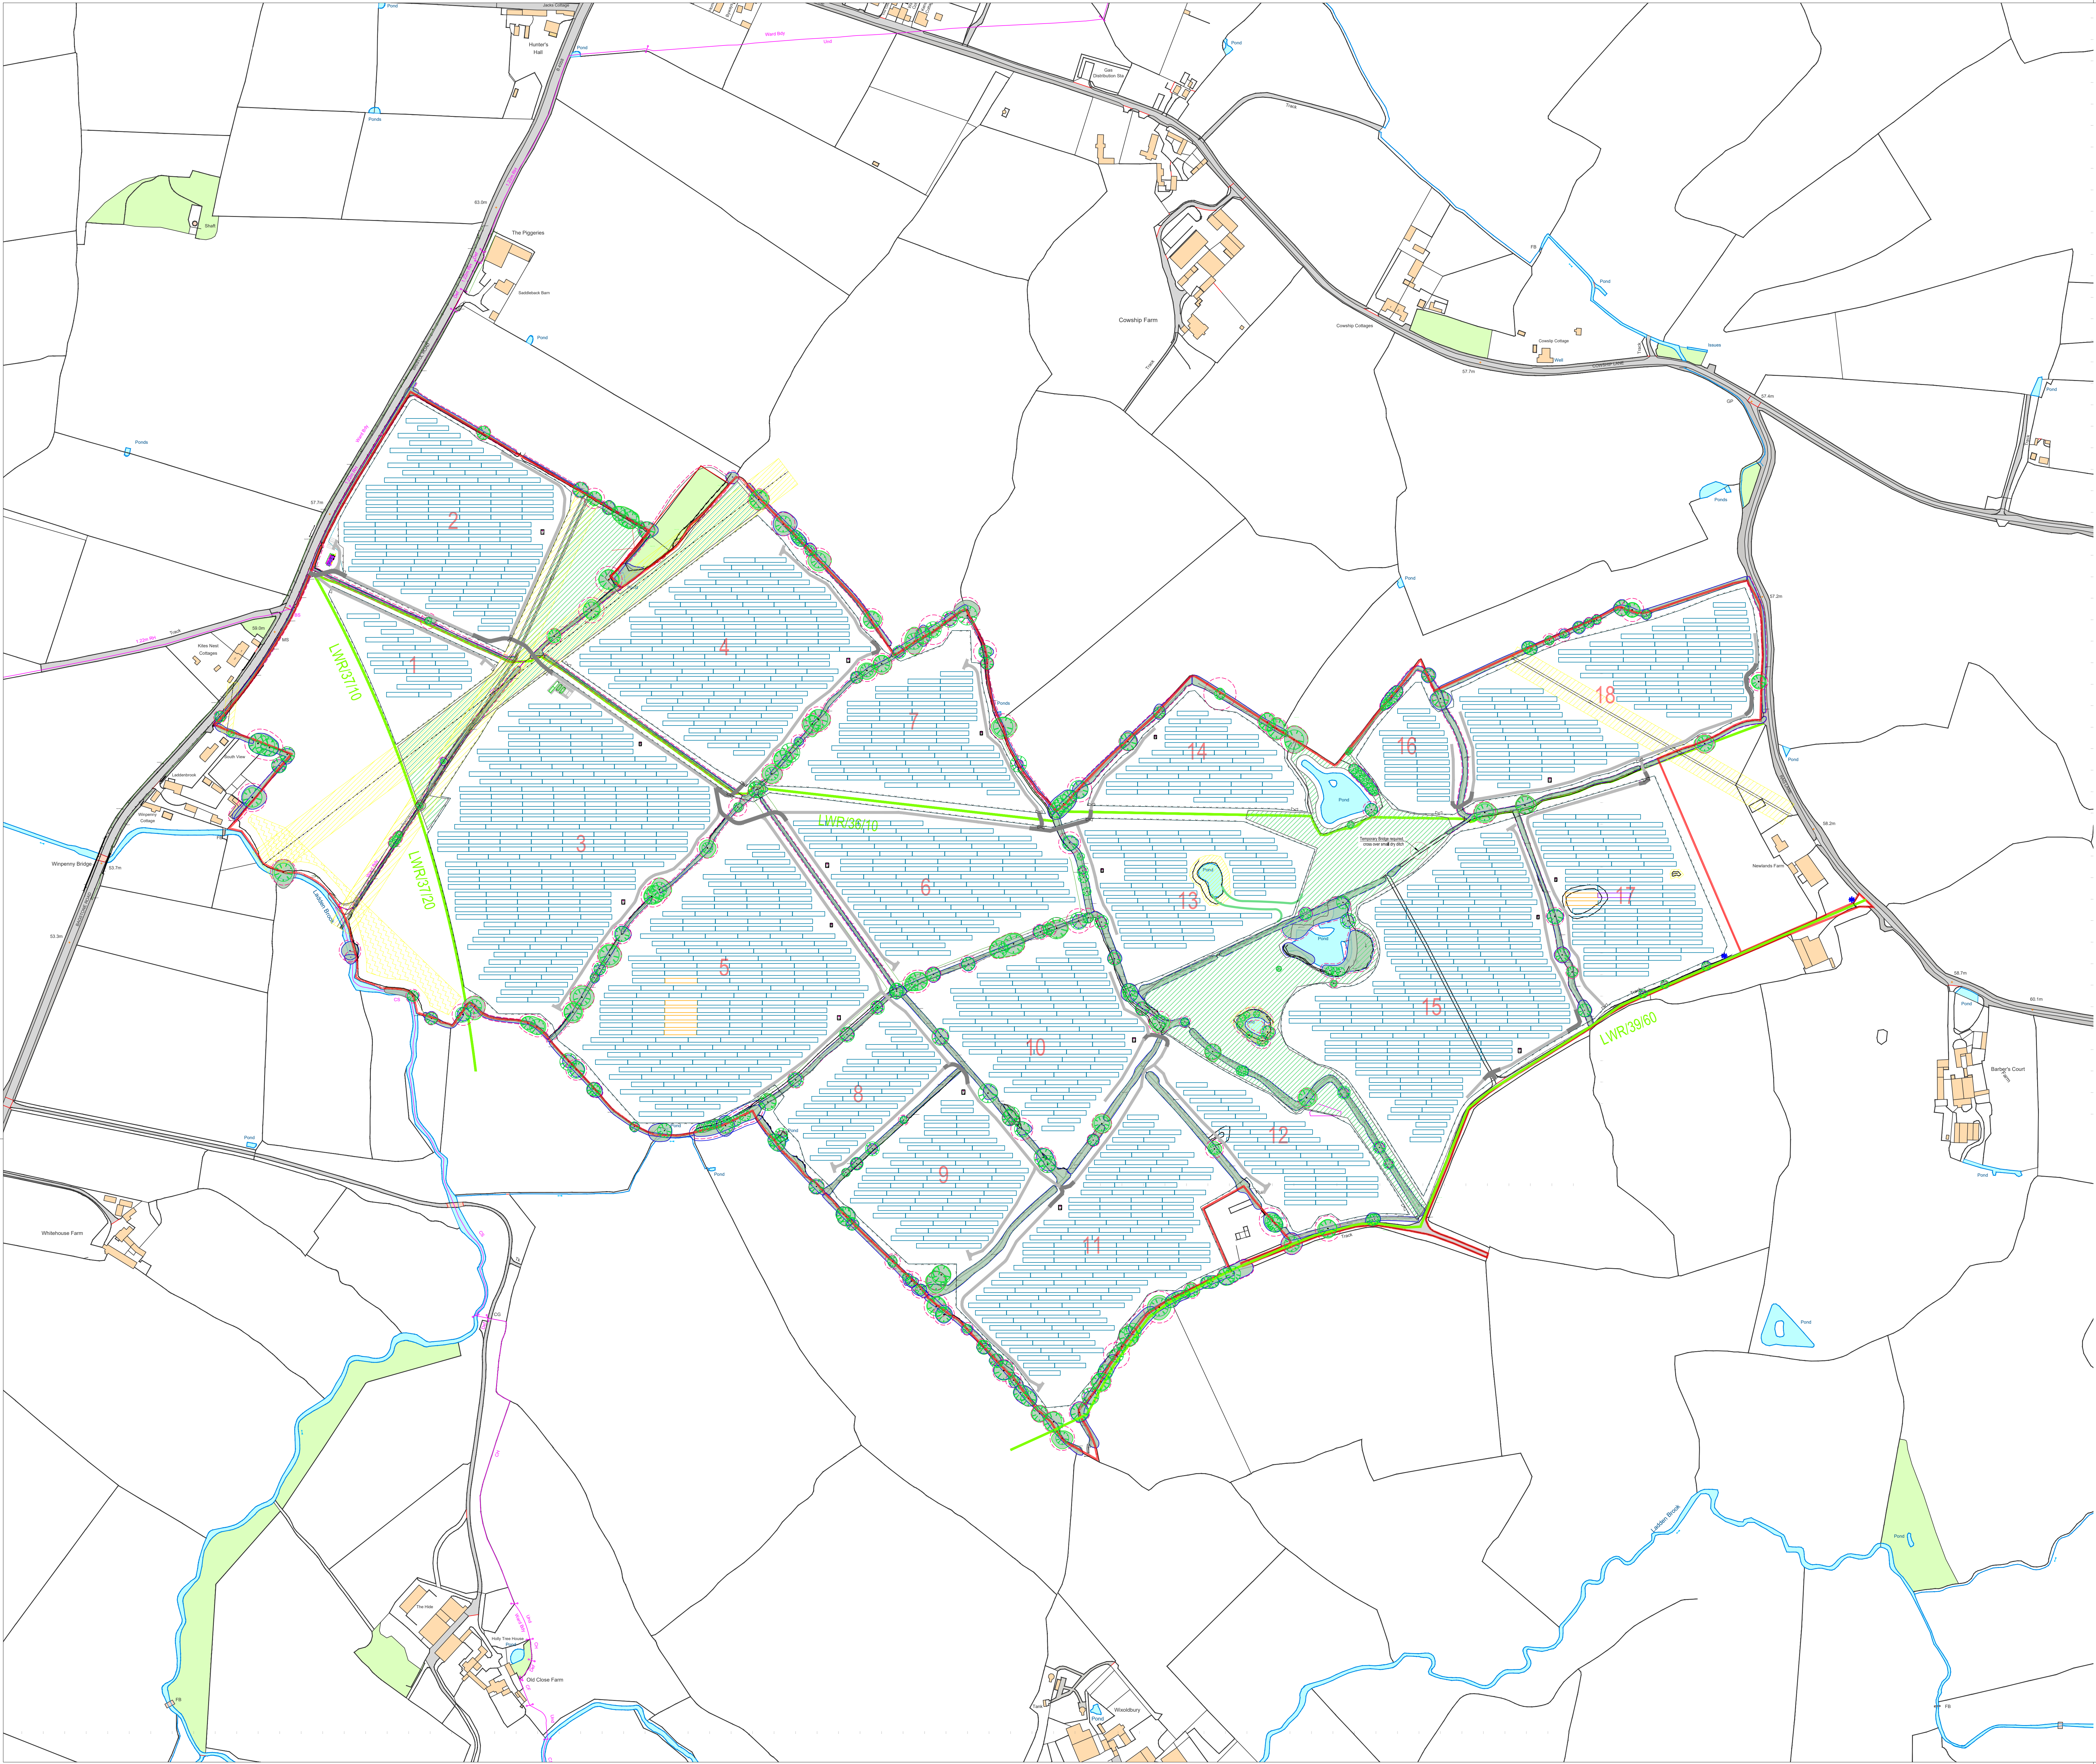

- Legend:**
- boundary
 - Module Unit
 - fence
 - gate (8m wide)
 - transformer station
 - gravel road
 - m width
 - storage container
 - substation & metering
 - water reservoir

j					
i					
h					
g					
f					
e					
d					
c					
b					
a					
Index	Date	Name	Editor	Modification / Adaptation of the drawing	
				Project:	Rag Lane UK PV Power Plant
				Client:	BayWa r.e. Solar Project
Drawn	28.07.2023	FPL		Planning Period:	
Changed	---	---			
Checked	---	---			
Drawing Title:	01_permitting				Scale 1:2.000
File Name:	BWre-RL-CD.dwg				Format A0